



© COPYRIGHT 2017, TISDELL ASSOCIATES.
WARNING: IT IS A VIOLATION OF SECTION 7209 OF THE NYS EDUCATION LAW FOR ANY PERSON, UNLESS ACTING UNDER THE DIRECTION OF A LICENSED PROFESSIONAL, TO ALTER THIS DRAWING. IF ALTERED, SUCH PERSON SHALL AFFIX THEIR SEAL, SIGNATURE, DATE, AND A DESCRIPTION OF THE ALTERATION.





REV	DATE	DESCRIPTION

DRAWN	ESR
CHECKED	DMT
DATE	AUGUST 2017
PROJECT	16-89


**MADRID HEPBURN LIBRARY
WHEELCHAIR LIFT
REPLACEMENT**

MADRID NEW YORK


**ELEVATOR HOISTWAY
PROPOSED PLAN**

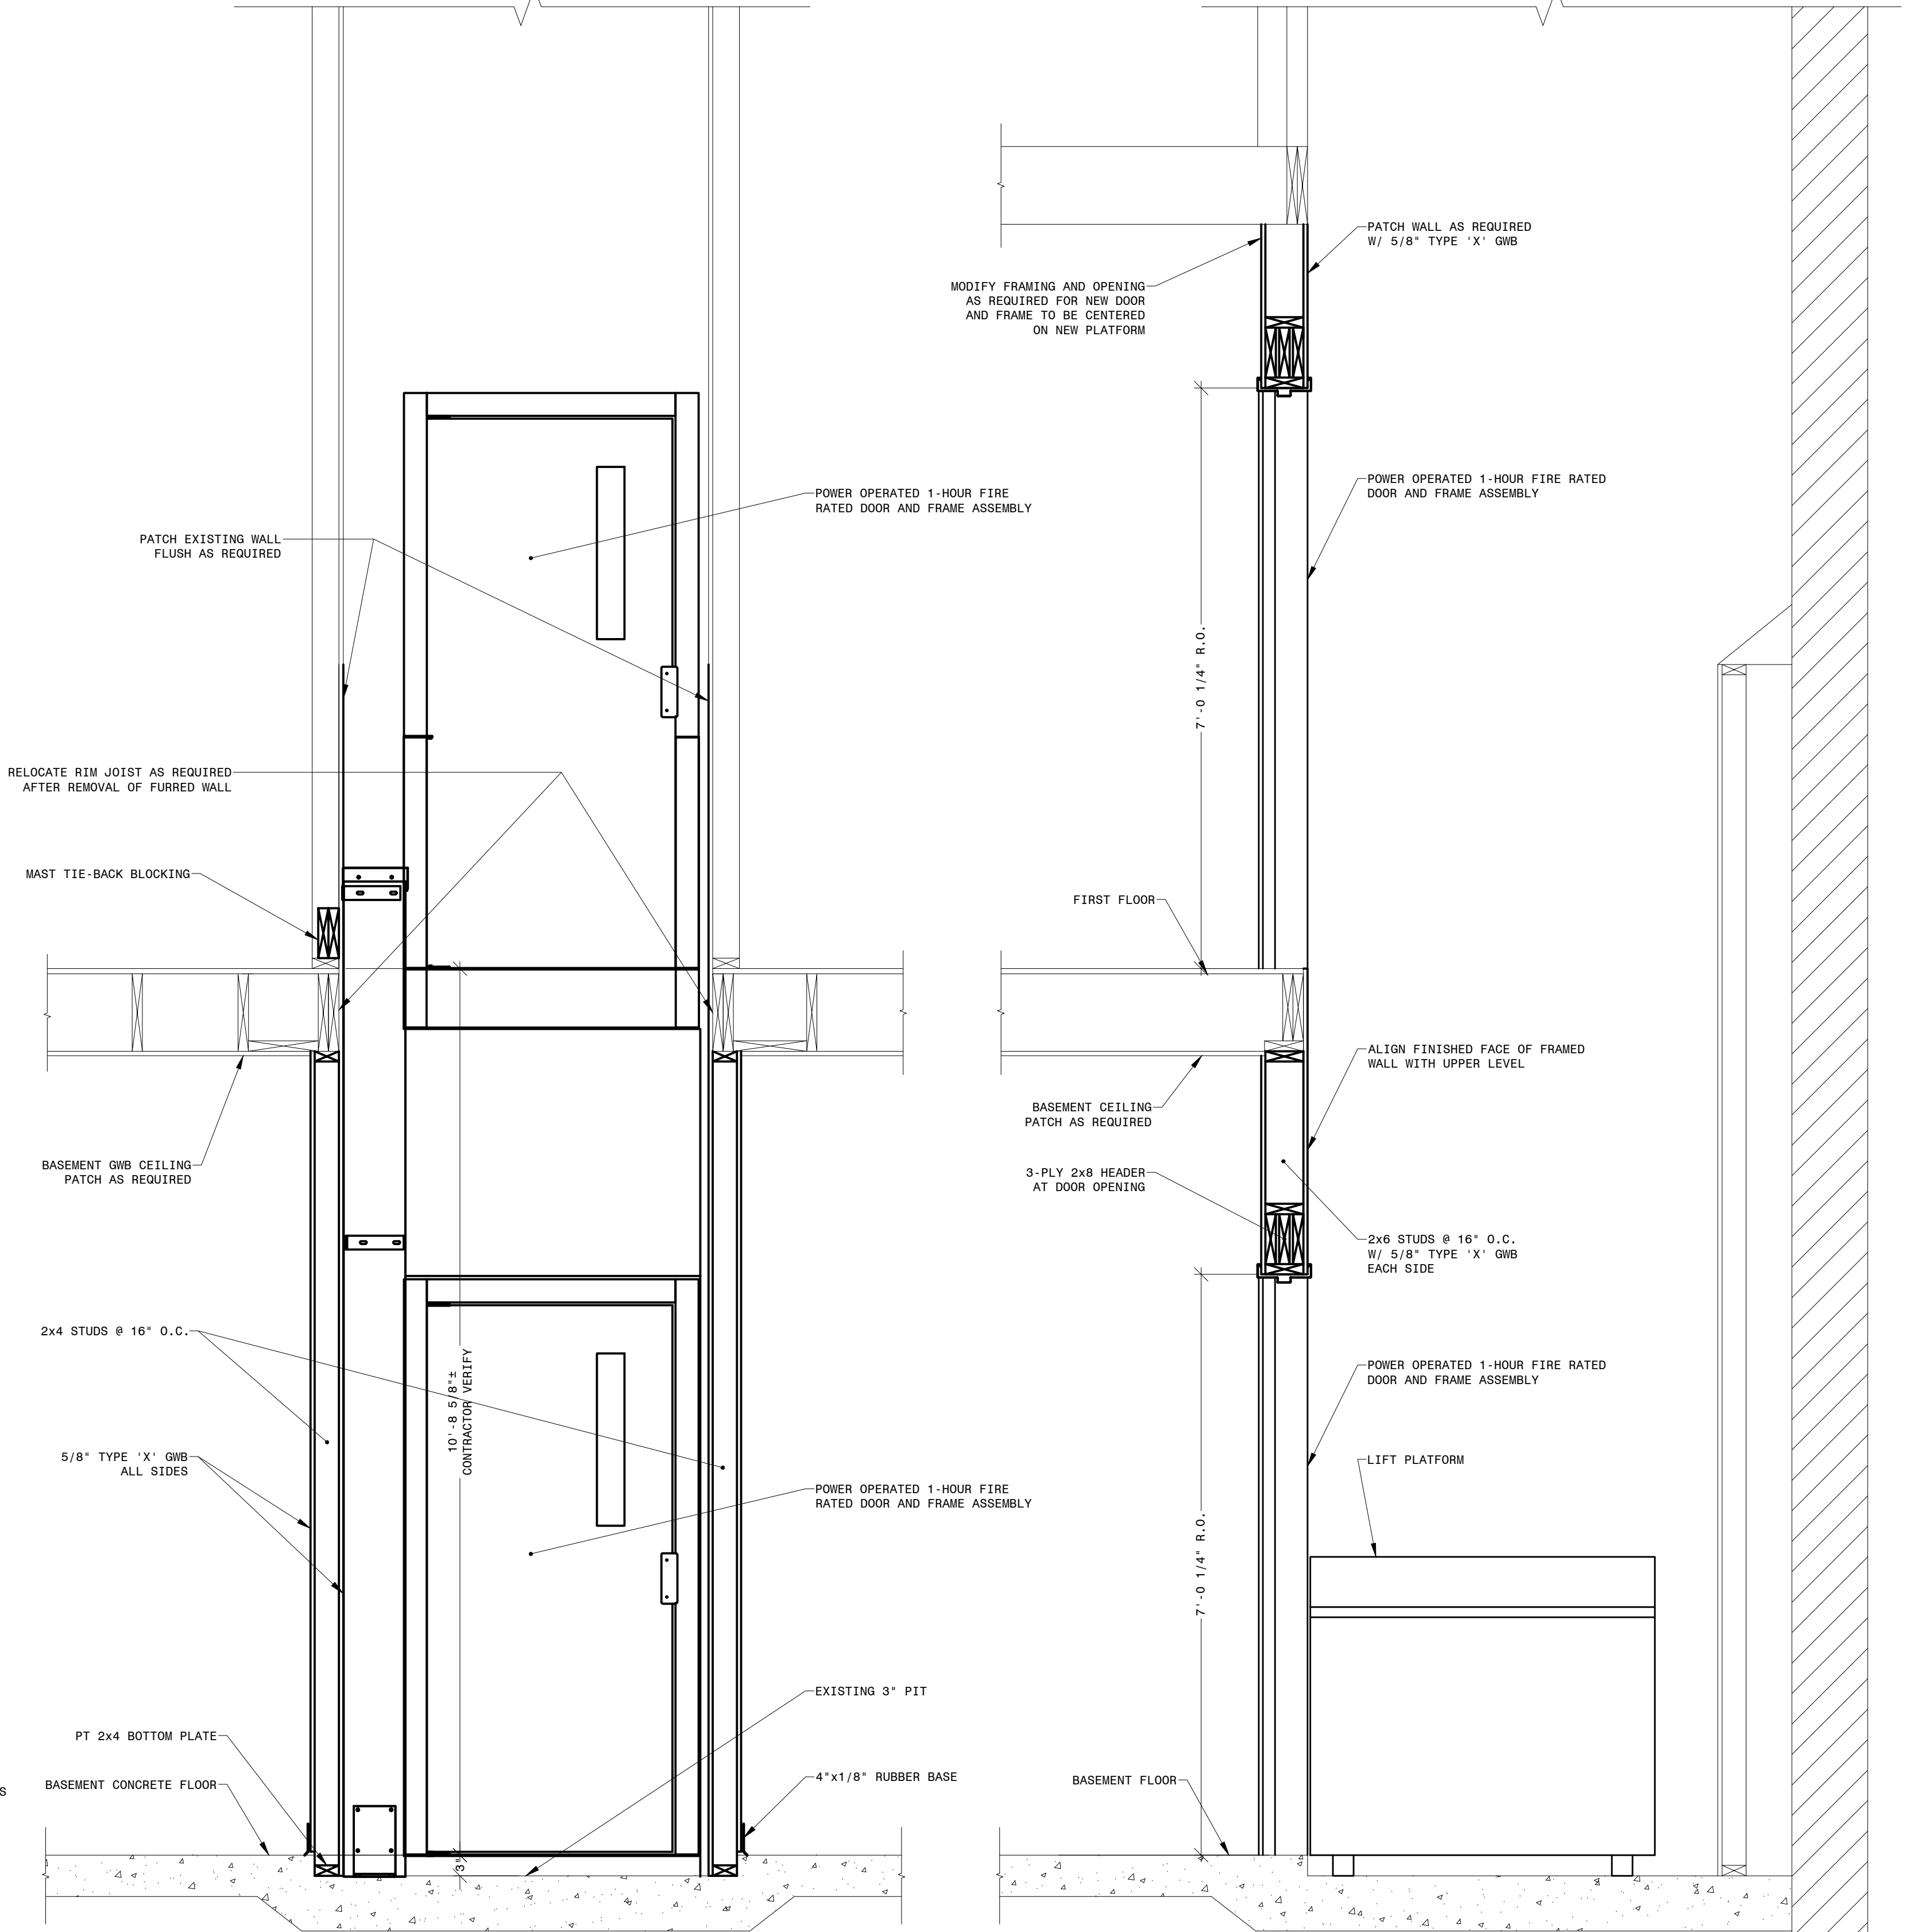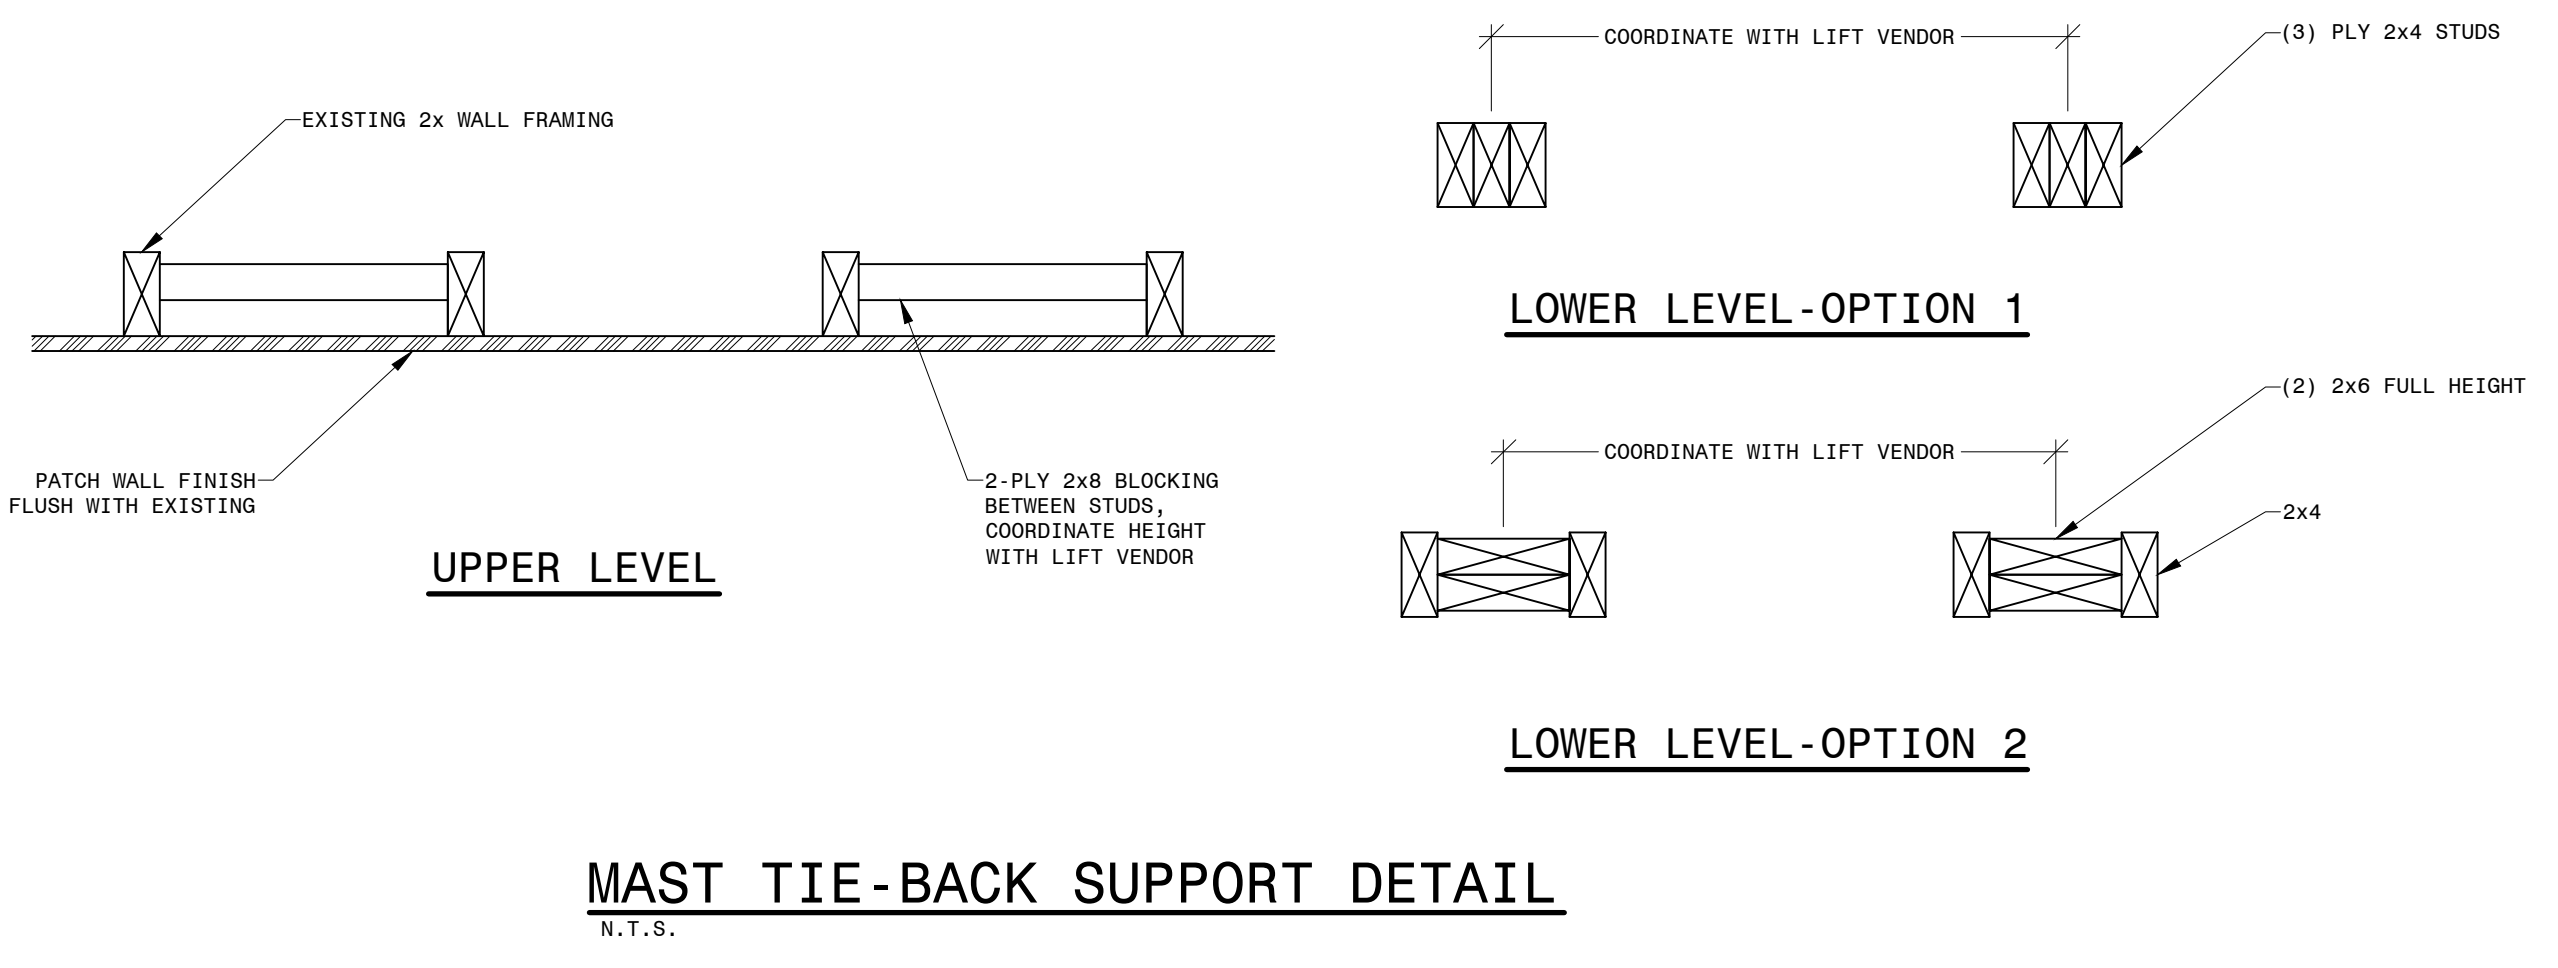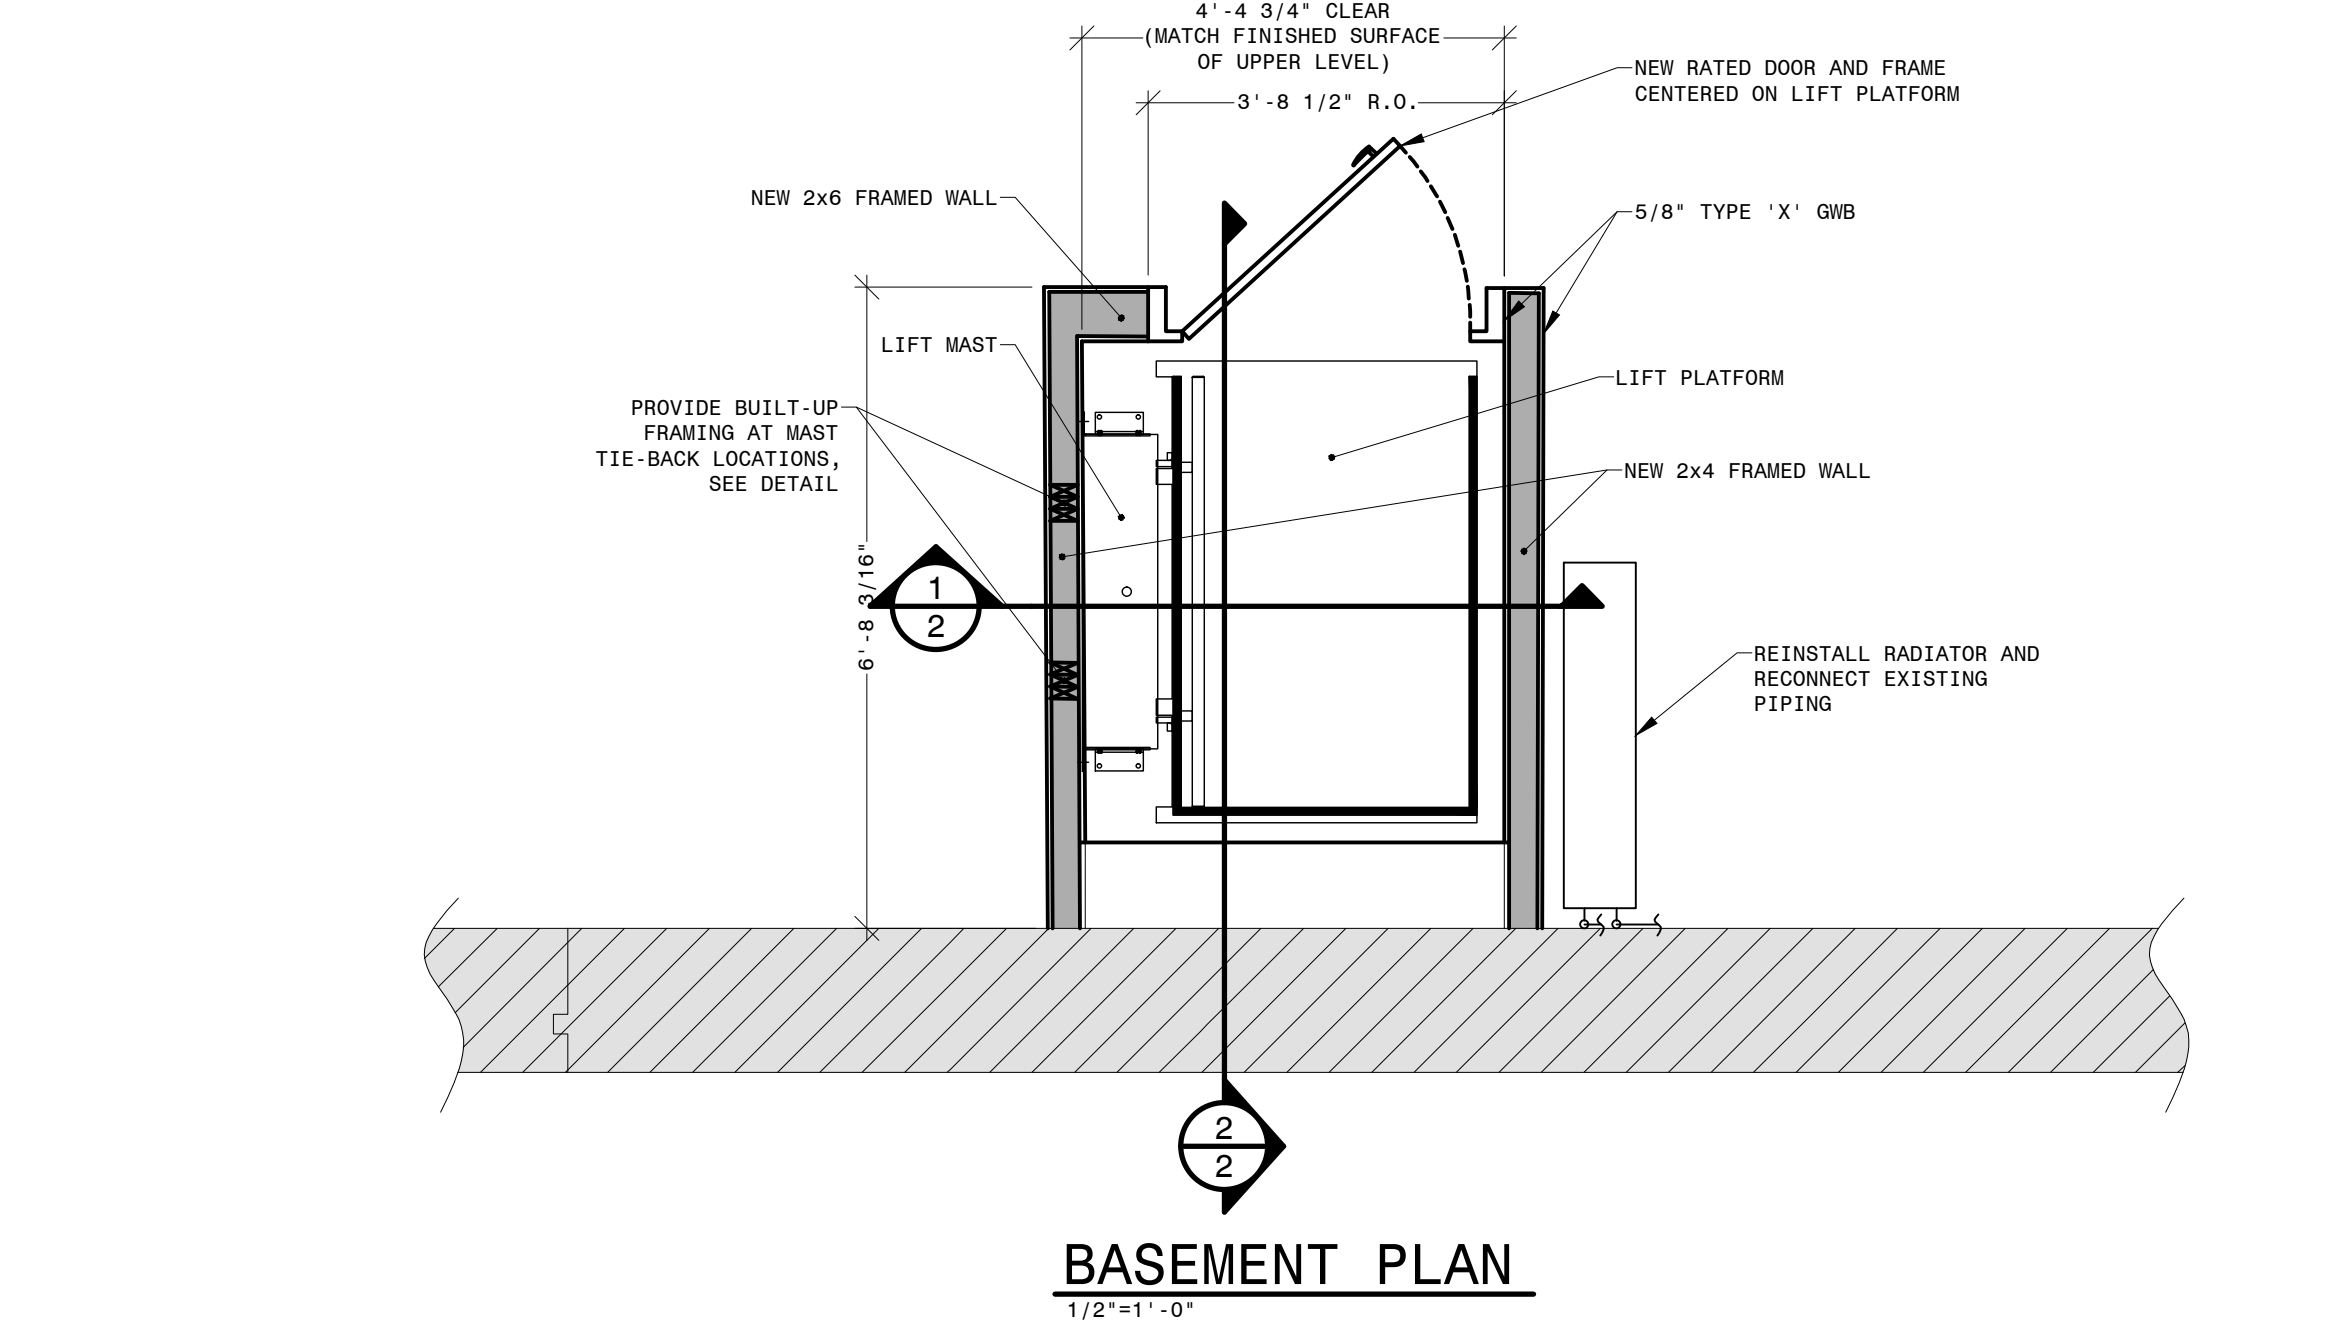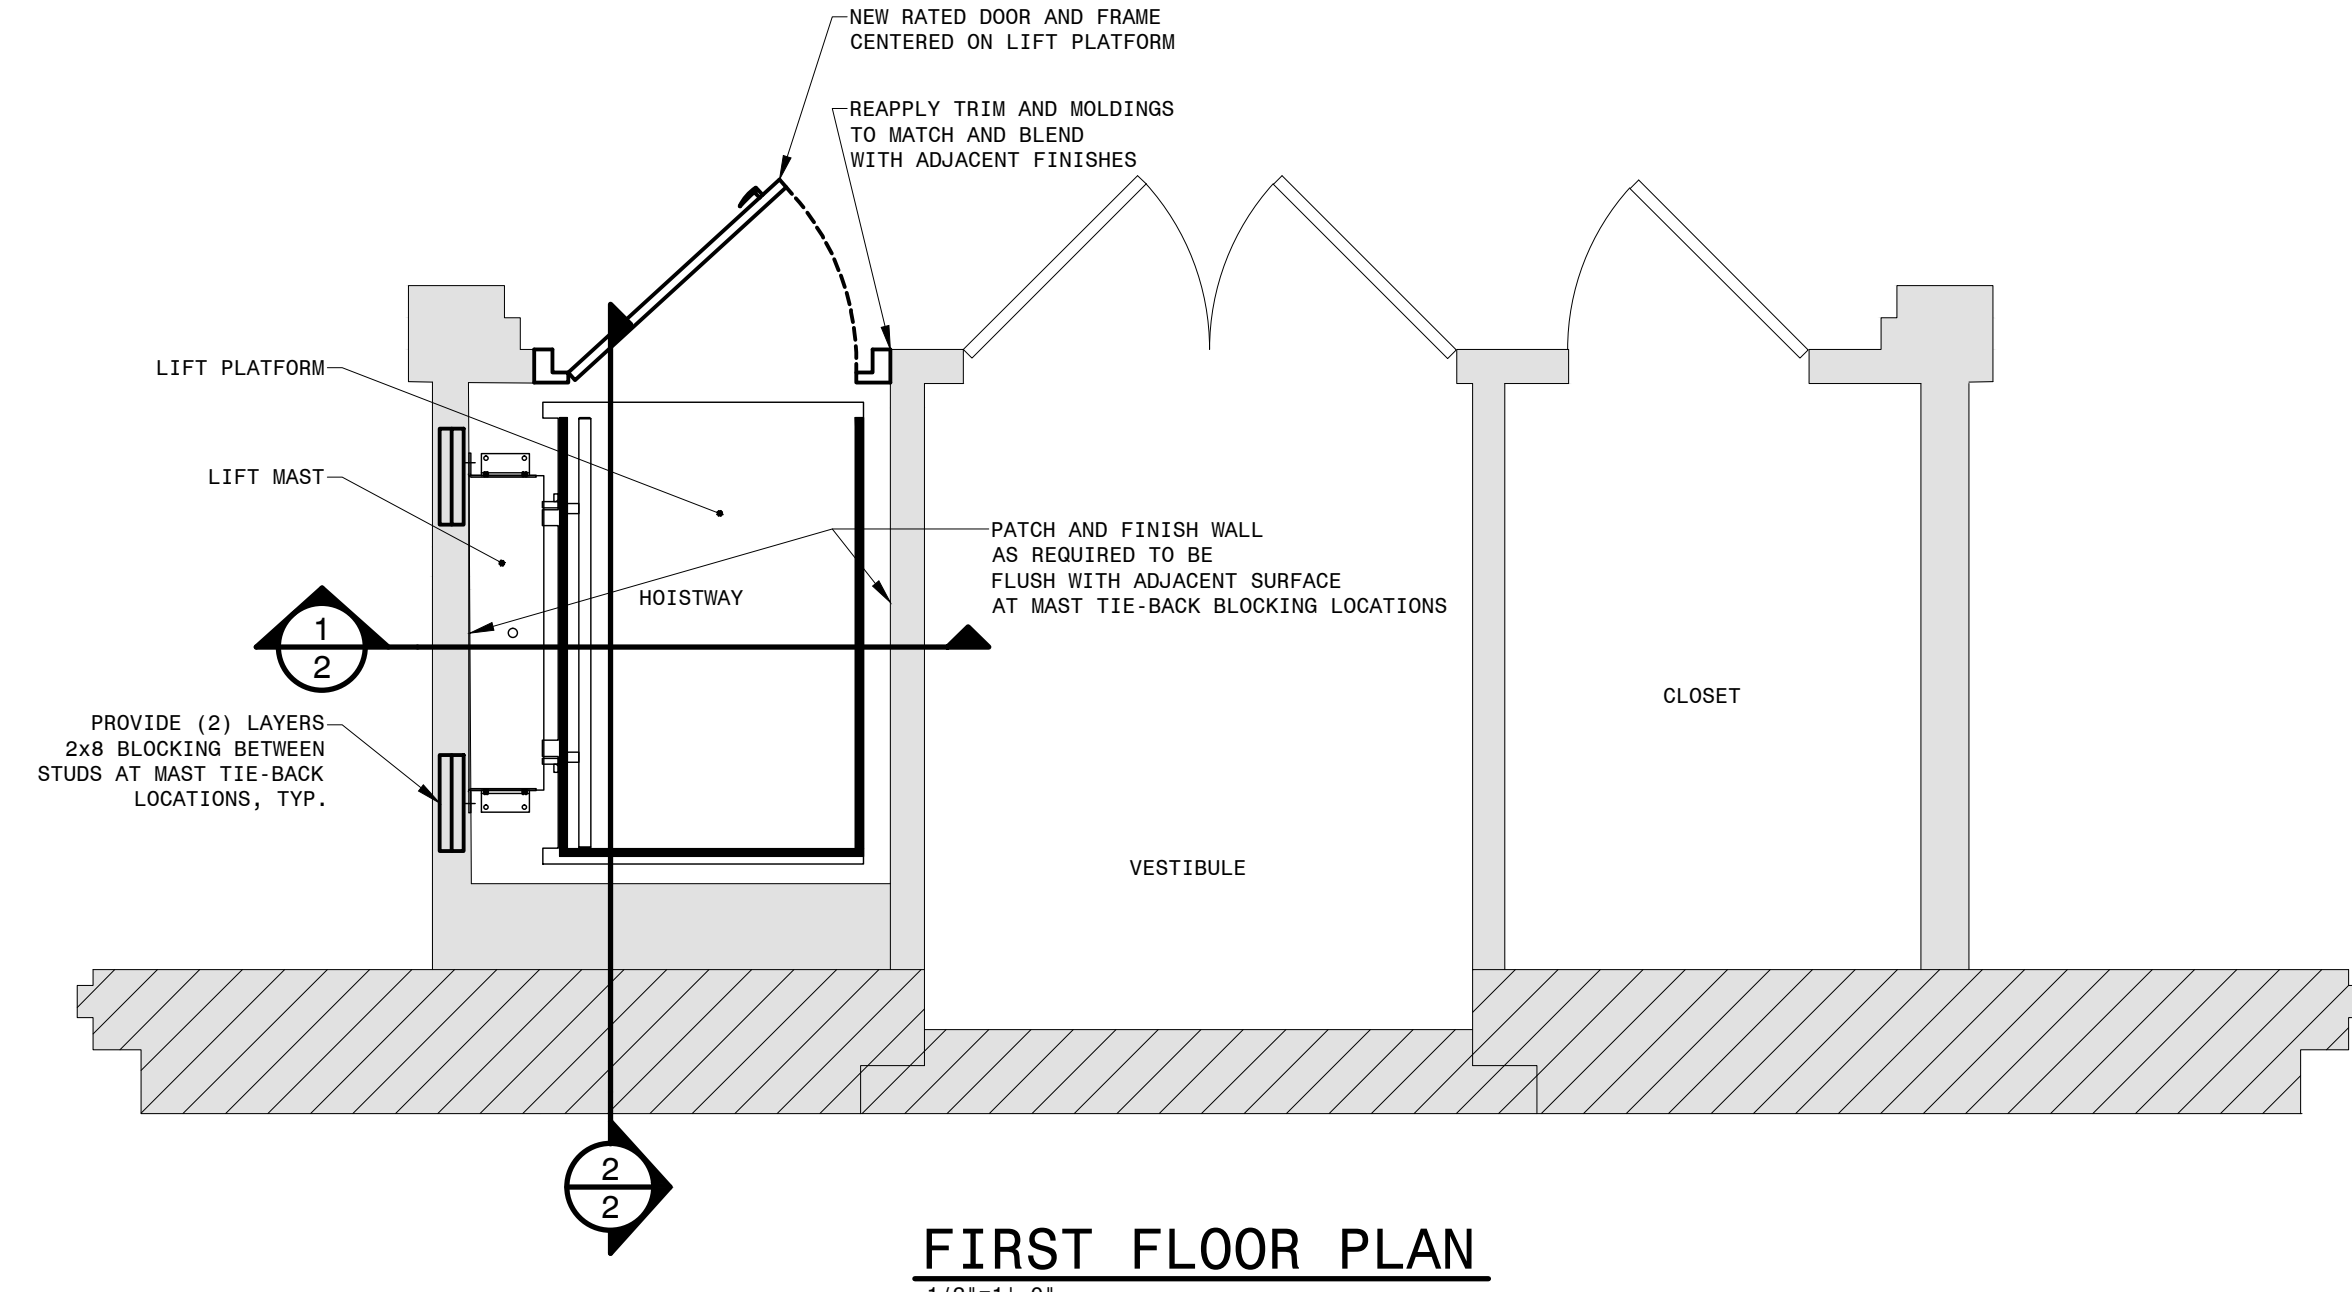

NOTE: LIFT MAST ASSEMBLY NOT SHOWN FOR CLARITY

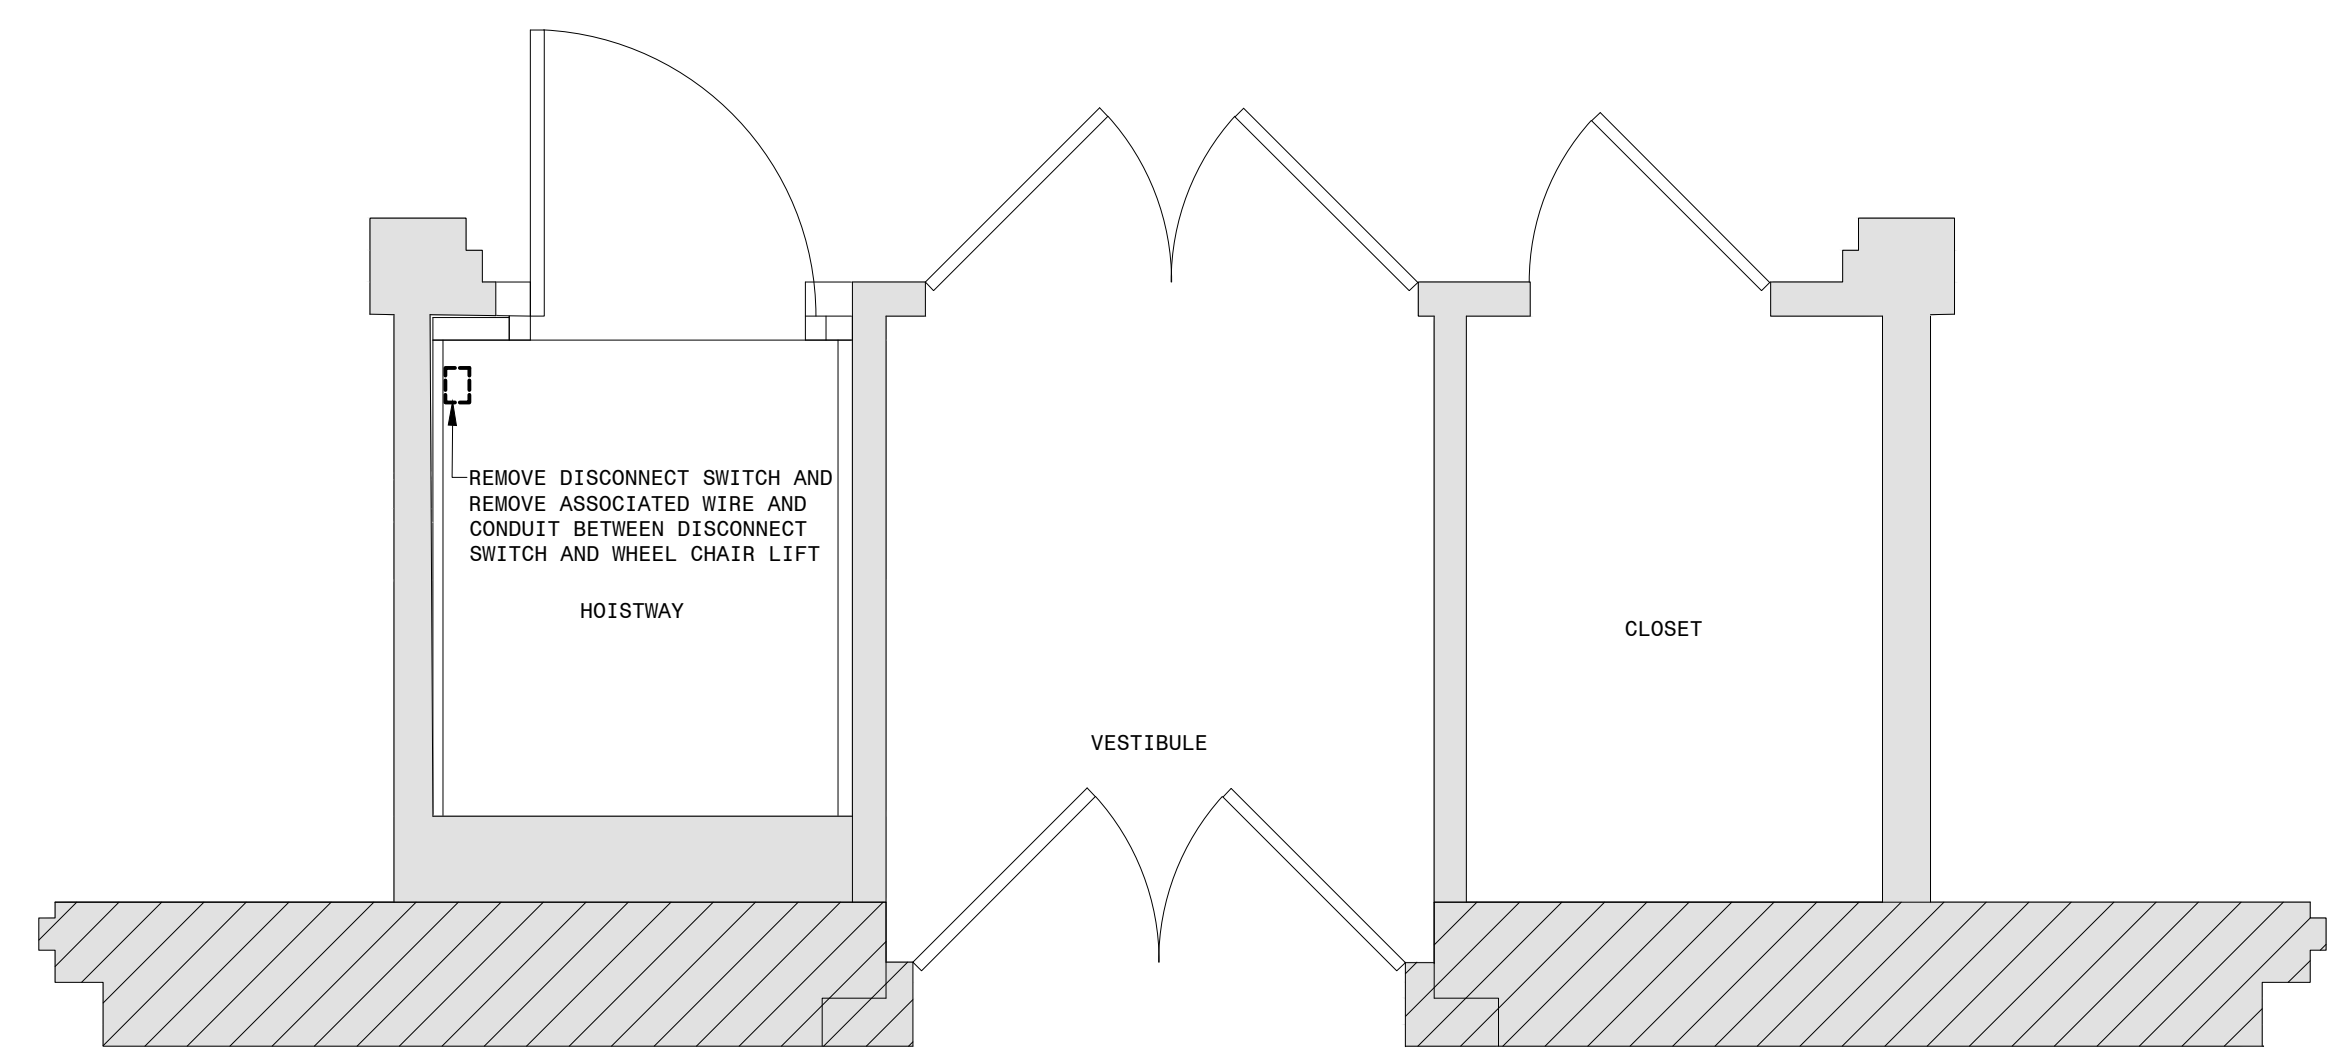


FIRST FLOOR DEMOLITION PLAN
1/2"=1'-0"

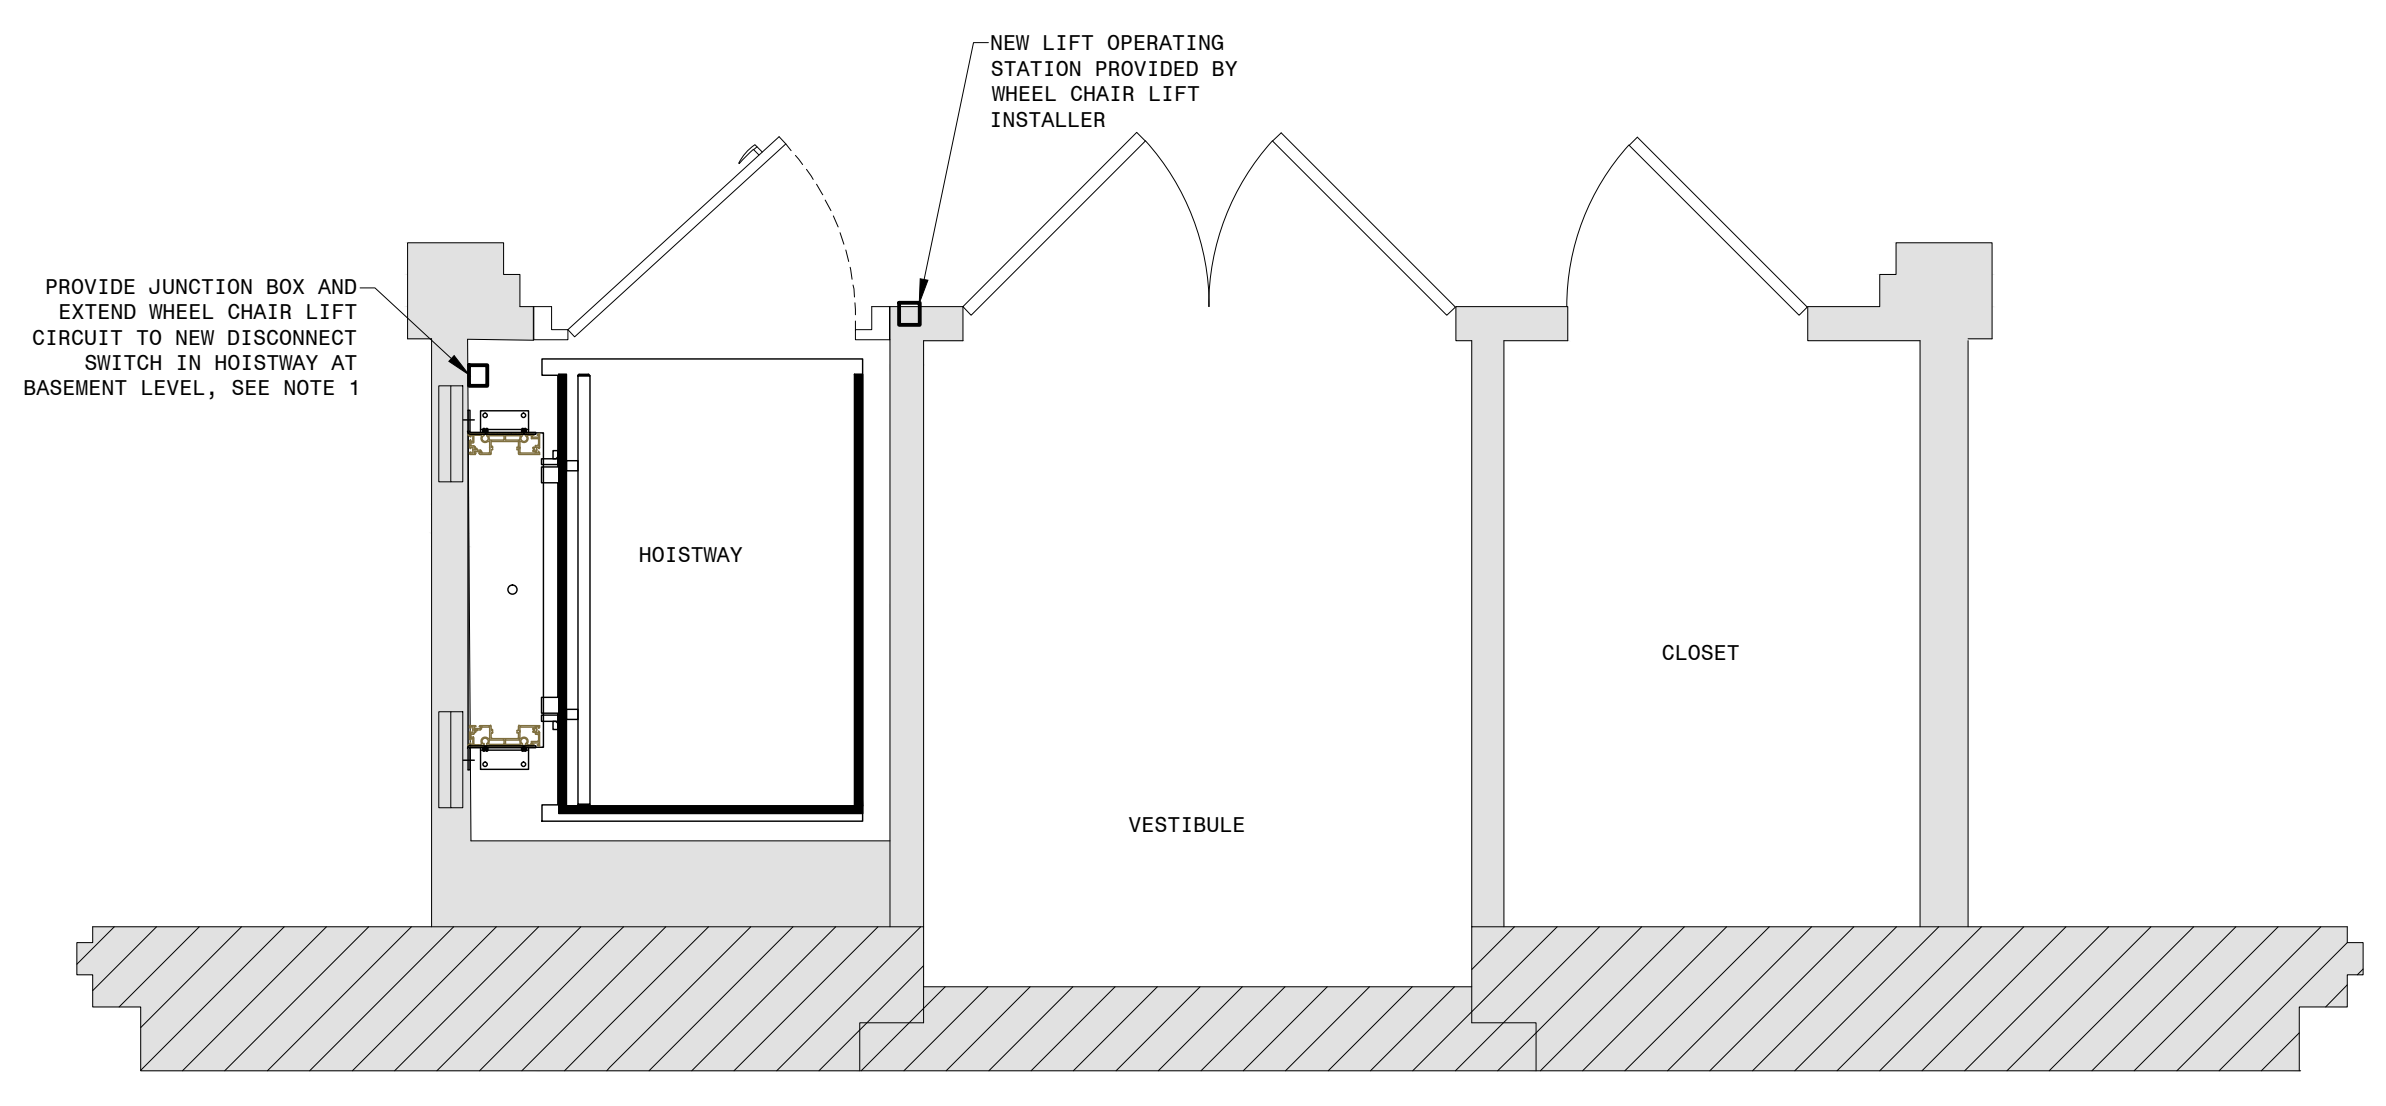


FIRST FLOOR PLAN
1/2"=1'-0"

- NOTES:
1. CIRCUIT EXTENSION TO NEW WHEEL CHAIR LIFT DISCONNECT SWITCH SHALL BE 2-#12, 1-#12 GROUND IN 1/2" EMT.
 2. PROVIDE 2-#12, 1-#12 GROUND IN 1/2" CONDUIT FROM NEW LIGHT SWITCH. CONCEAL WIRING IN NEW HOISTWAY WALLS WHERE POSSIBLE. ANY WIRING SURFACE MOUNTED ON INTERIOR OF HOISTWAY SHALL BE INSTALLED IN EMT. CONCEALED WIRING SHALL BE MC CABLE.

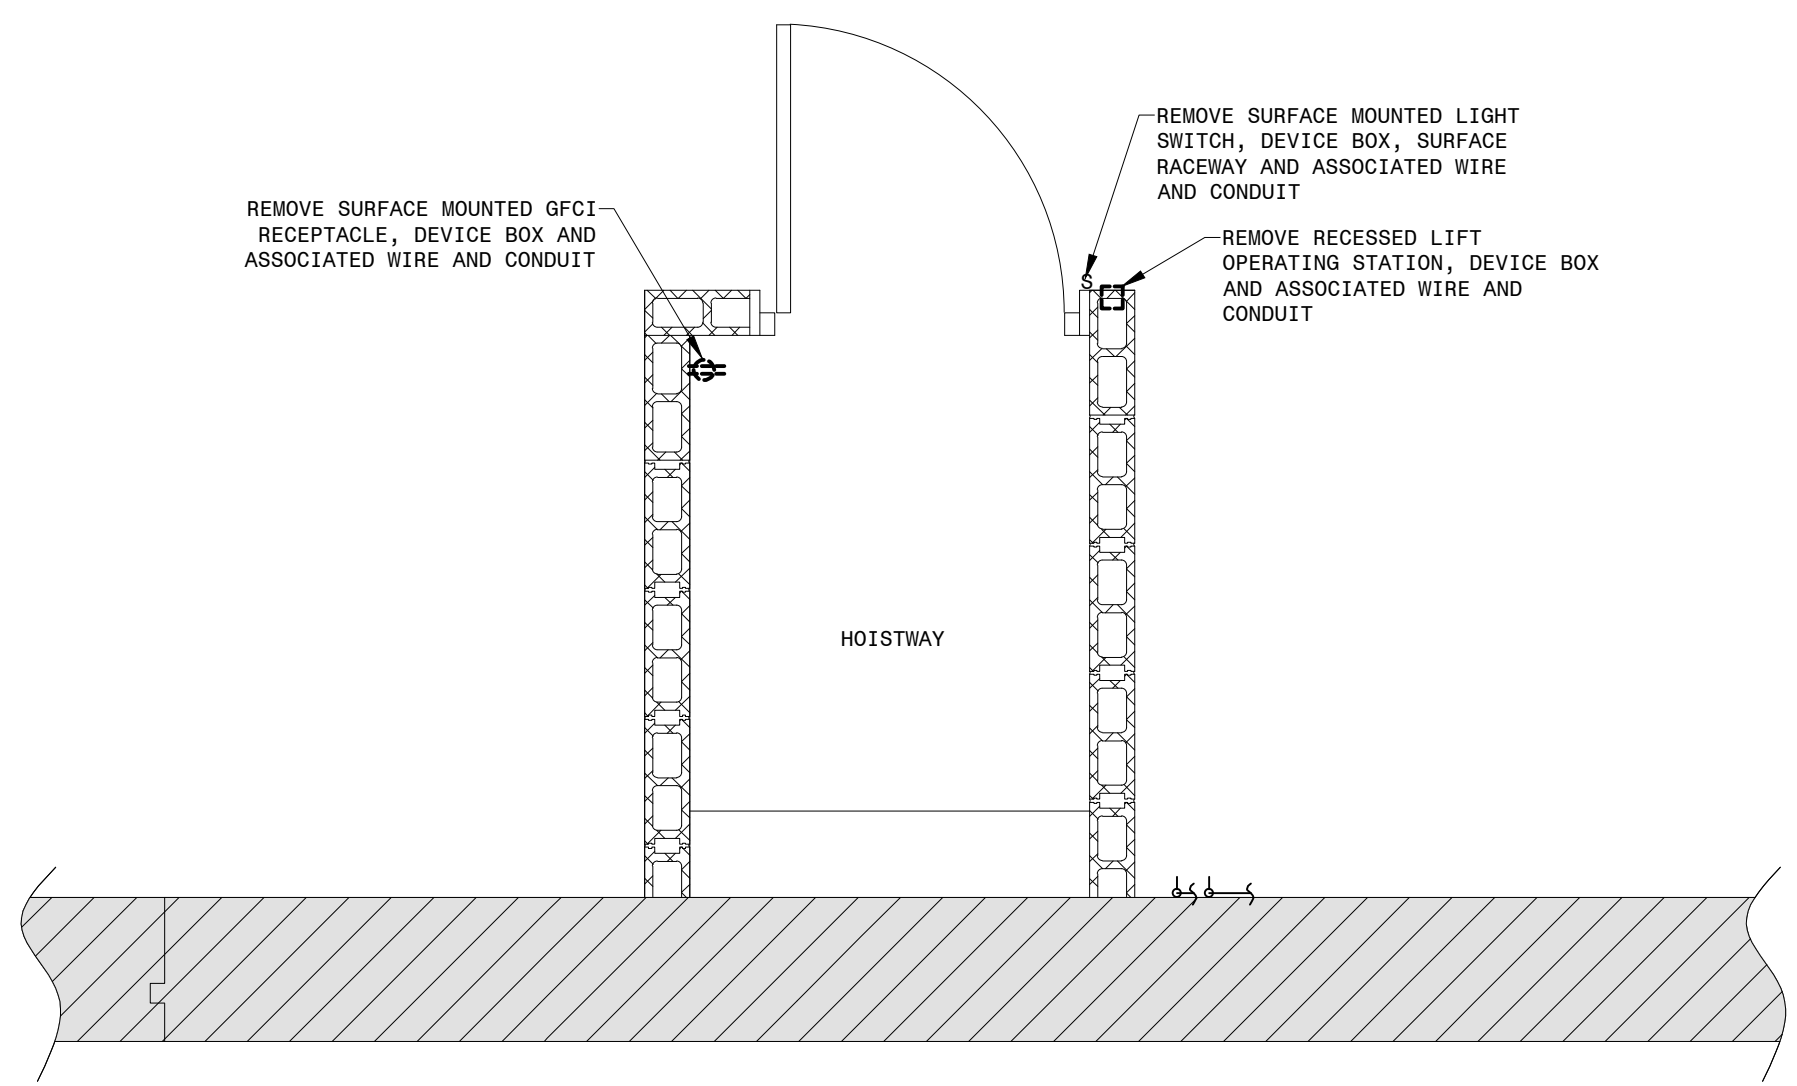

BASEMENT DEMOLITION PLAN
1/2"=1'-0"

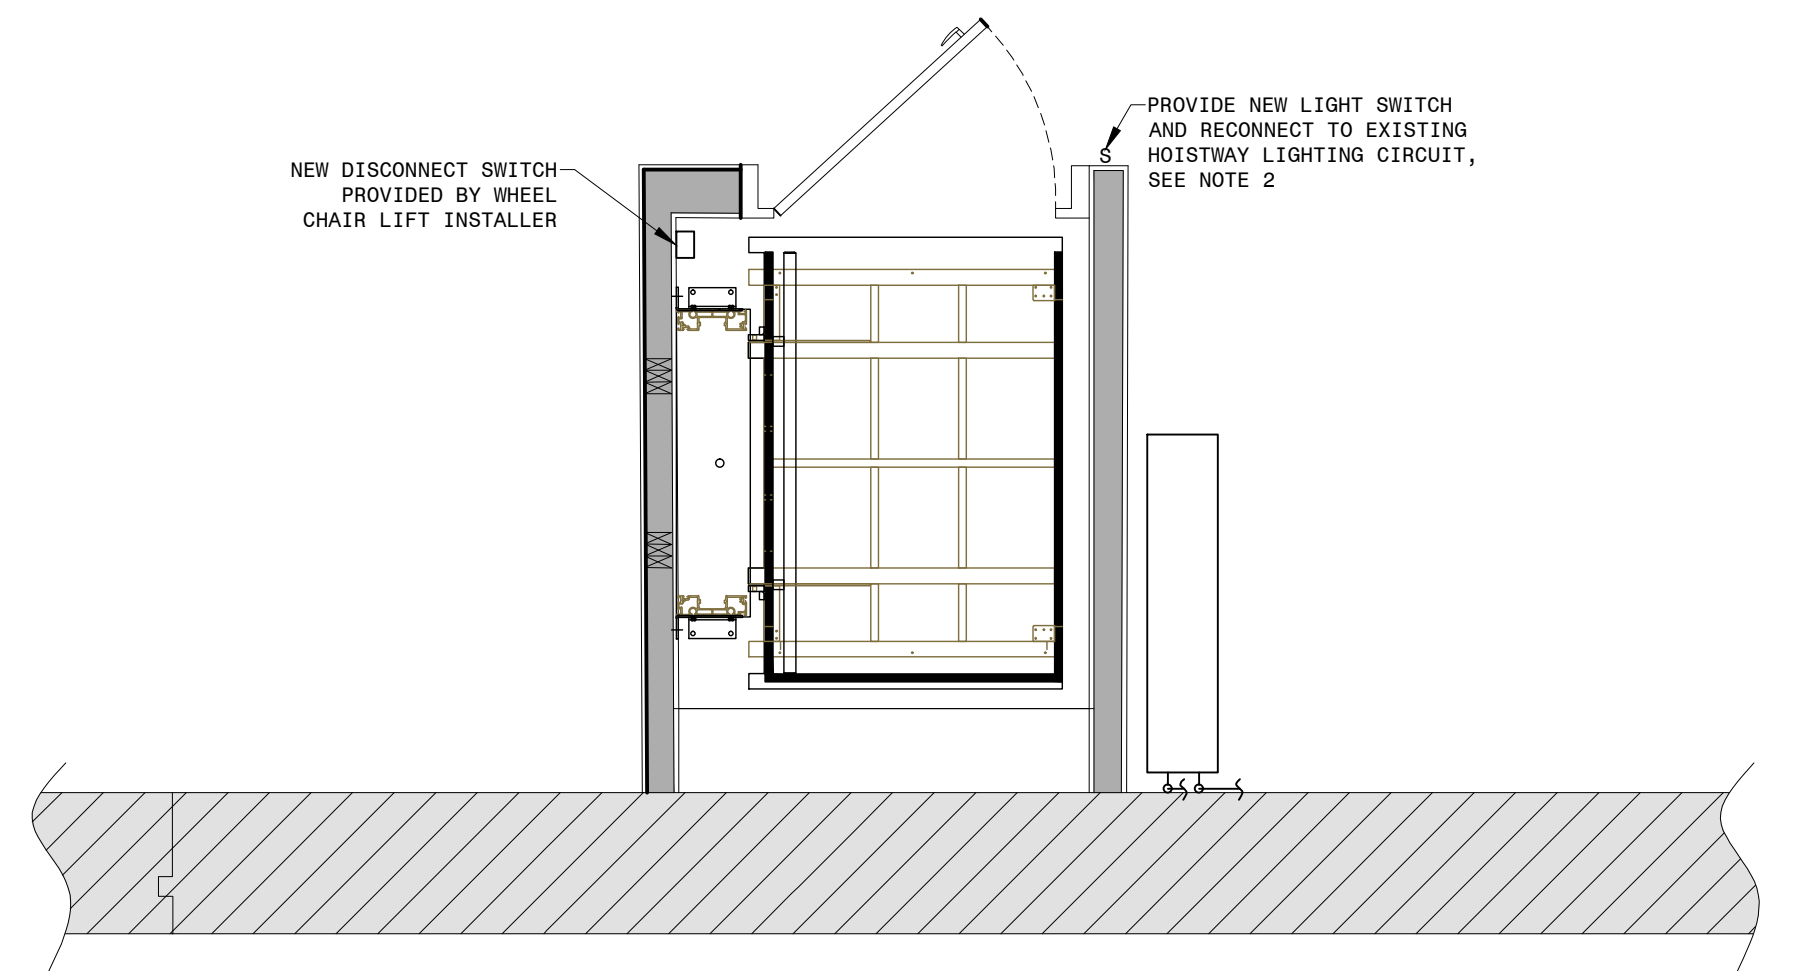

BASEMENT PLAN
1/2"=1'-0"



© COPYRIGHT 2017, TISEL ASSOCIATES.
WARNING: IT IS A VIOLATION OF SECTION 7209 OF THE NYS EDUCATION LAW FOR ANY PERSON, UNLESS ACTING UNDER THE DIRECTION OF A LICENSED PROFESSIONAL, TO ALTER THIS DRAWING. IF ALTERED, SUCH PERSON SHALL AFFIX THEIR SEAL, SIGNATURE, DATE, AND A DESCRIPTION OF THE ALTERATION.

REV	DATE	DESCRIPTION

DRAWN	JRM
CHECKED	MJC
DATE	AUGUST 2017
PROJECT	16-89

MADRID HEPBURN LIBRARY
WHEELCHAIR LIFT REPLACEMENT

MADRID NEW YORK

ELECTRICAL PLAN